 



NOTE
Drainage layouts have been derived from archived records and limited site survey and are to be exposed, assessed and agreed with Building Control before works proceed on site.

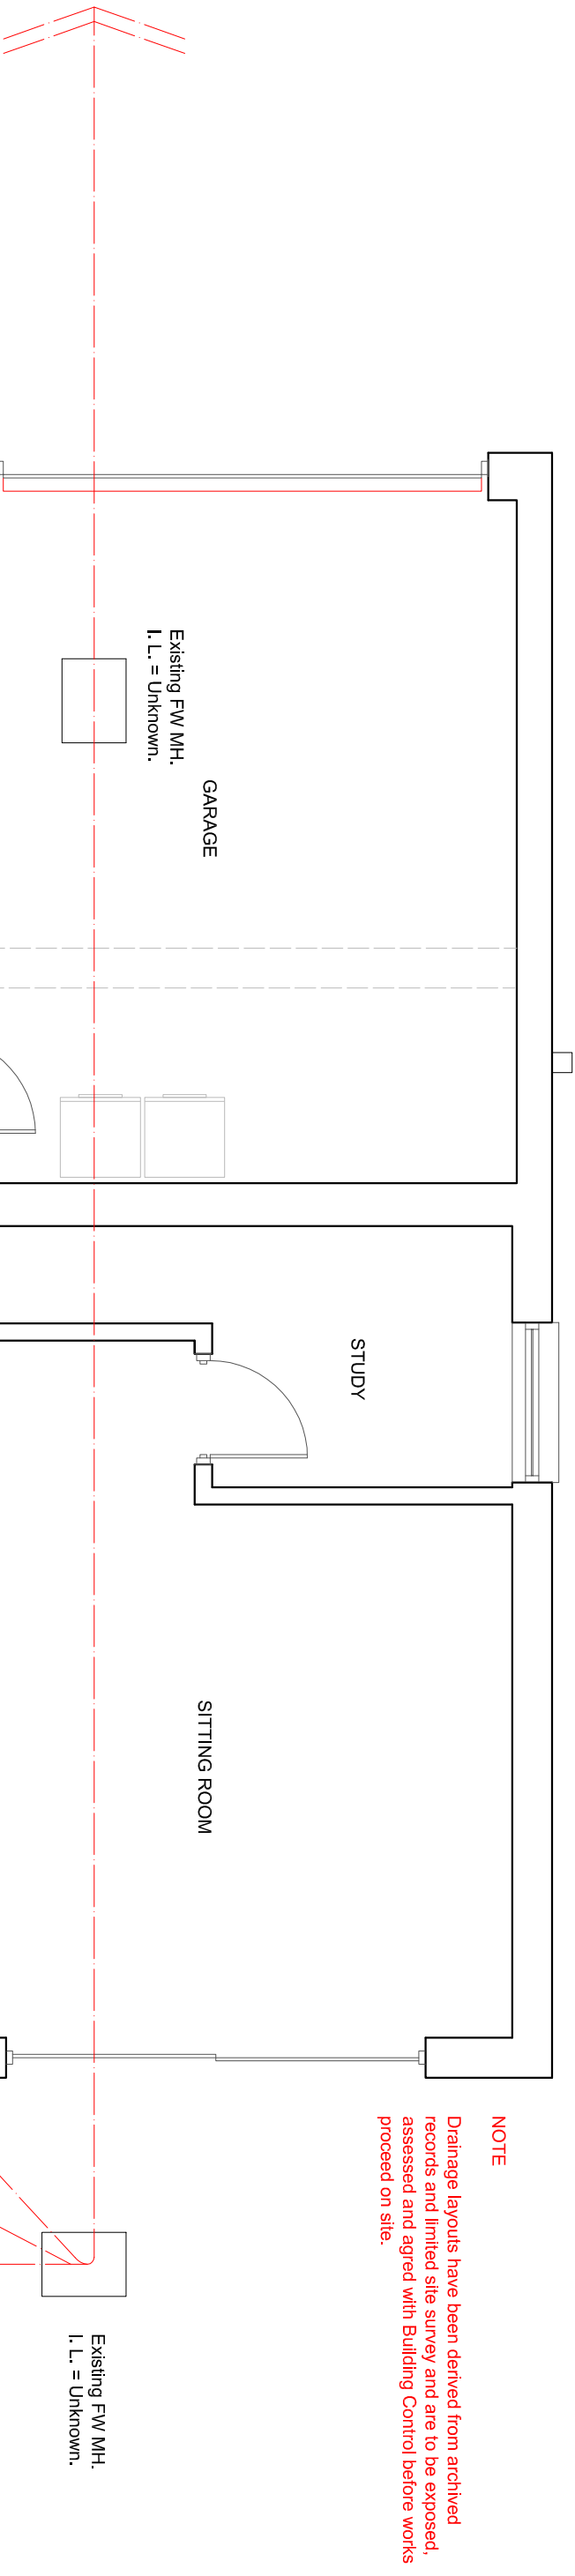

Scale 1:50 on A3

EXISTING GROUND FLOOR PLAN

SUSSEX BUILDING CONSULTANCY LIMITED

7 MEADOW WAY, ALDWICK,
BOGNOR REGIS, WEST SUSSEX.

SCALE - 1/50 REV - DATE - 29/10/2024

LABC partner

3 NORTHGATE ROAD
BOGNOR REGIS
PO21 5LZ
TEL/FAX - (01243) 861379