 
 



SCALE 1:100




NW ELEVATION



 SW ELEVATION




SE ELEVATION

 

NE ELEVATION

NOTE
DO NOT SCALE FROM THIS DRAWING EXCEPT FOR PLANNING PURPOSES.
ALL DIMENSIONS TO BE CHECKED ON SITE PRIOR TO COMMENCEMENT OF WORK. ALL DIMENSIONS RELATING TO SUB-CONTRACTORS OR APPLIES WORK MUST BE CHECKED AND AGREED BETWEEN THE SUB-CONTRACTORS AND/OR SUPPLIERS, AND MUST BE CARRIED OUT IN ACCORDANCE WITH THE RELEVANT CODES OF PRACTICE OR RECOGNISED TRADE ASSOCIATION RECOMMENDATIONS AND PUBLICATIONS.
THIS DRAWING TO BE READ IN CONJUNCTION WITH ALL RELEVANT DRAWINGS AND SPECIFICATIONS OF OTHER CONSULTANTS.
ANY DISCREPANCIES TO BE BROUGHT TO THE ATTENTION OF BAQUS GROUP PLC. IF IN DOUBT ASK.
© THIS DRAWING IS THE COPYRIGHT OF BAQUS GROUP PLC.

APPR DATE STATUS

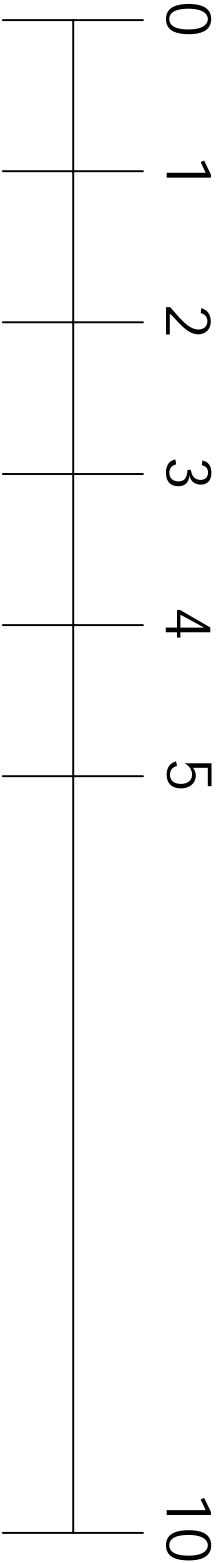

SCALE 1:50



FLOOR PLAN

A	SEPT 2024	DVS	FLOOR PLAN SCALE BAR CORRECTED	
---	-----------	-----	--------------------------------	--

REV	DATE	AMENDMENT	BY
-----	------	-----------	----

PROJECT
JOHN WILEY & SONS LTD
DISTRIBUTION CENTRE, BOGNOR
NEW PUMP HOUSE

DRAWING
PROPOSED ELEVATIONS AND FLOOR
PLAN

Date	AUGUST 2024	Drawn By	DVS
Scale	1: 100 / 1:50 @ A3	Iss. App. By	SO
Drawing No	007901.004 A	File Location	007901



2/3 NORTH MEWS
LONDON, WC1N 2JP
TEL: 020 7831 1283 FAX: 020 7242 9512
e-mail: enquiries@baqus.co.uk
www.baqus.co.uk